


CIVIL LEGEND	
SURFACE WATER	
Ex. WASTE WATER	
WASTE WATER	
FOUL ACCESS JUNCTION	
SURFACE ACCESS JUNCTION	
FOUL INSPECTION CHAMBER	
SURFACE INSPECTION CHAMBER	
RAINWATER PIPE	
SOIL VENT PIPE	
ROAD GULLEY	
BACK INLET GULLEY TRAP	
FOUL RODDING EYE	
SURFACE RODDING EYE	
GULLEY TRAP	
Ex. WATERMAIN	
WATERMAIN	
SLUICE VALVE	
SCOUR VALVE	
AIR VALVE	
FIRE HYDRANT	
MAGNETIC FLOW WATER METER	
IRRIGATION VALVE	
TRUST BLOCK	

Rev	Sts	Description	Date
P02	S2	Issued for IW Comments	20.07.20
P03	S2	Issued for Information - Site Plan Updated	16.09.20
P04	S2	Issued for Information - Site Plan Updated	15.03.21
P05	S2	Issued for Information - Site Plan Updated	13.04.21
P06	S2	Issued for Information - Site Plan Updated	21.03.22
P07	S2	Issued for Planning	15.07.22
P08	S2	Issued for Planning	27.09.23
P09	S2	Issued for Information	14.06.24

MMOS MURPHY · MATSON · O'SULLIVAN CONSULTING CIVIL & STRUCTURAL ENGINEERS		The Chapel, Blackrock House, Blackrock Road Cork, T12 KRK7 Tel : 353 21 4317608
PROJECT Proposed Development at Courtstown, Little Island, Co. Cork		
CLIENT Ruden Homes Ltd.		
TITLE Proposed Watermain Layout Plan Sheet 2 of 2		
DRAWN BY G.S.	CHECKED BY P.M.	APPROVED BY P.M.
SCALE As Shown	PROJECT NUMBER 20093	
DOCUMENT REFERENCE 20093-MMS-ZZ-ST-DR-C-10007		STATUS S2
PROJECT-ORIGINATOR-ZONE-LEVEL-TYPE-DICIPLINE-NUMBER		REV: P09

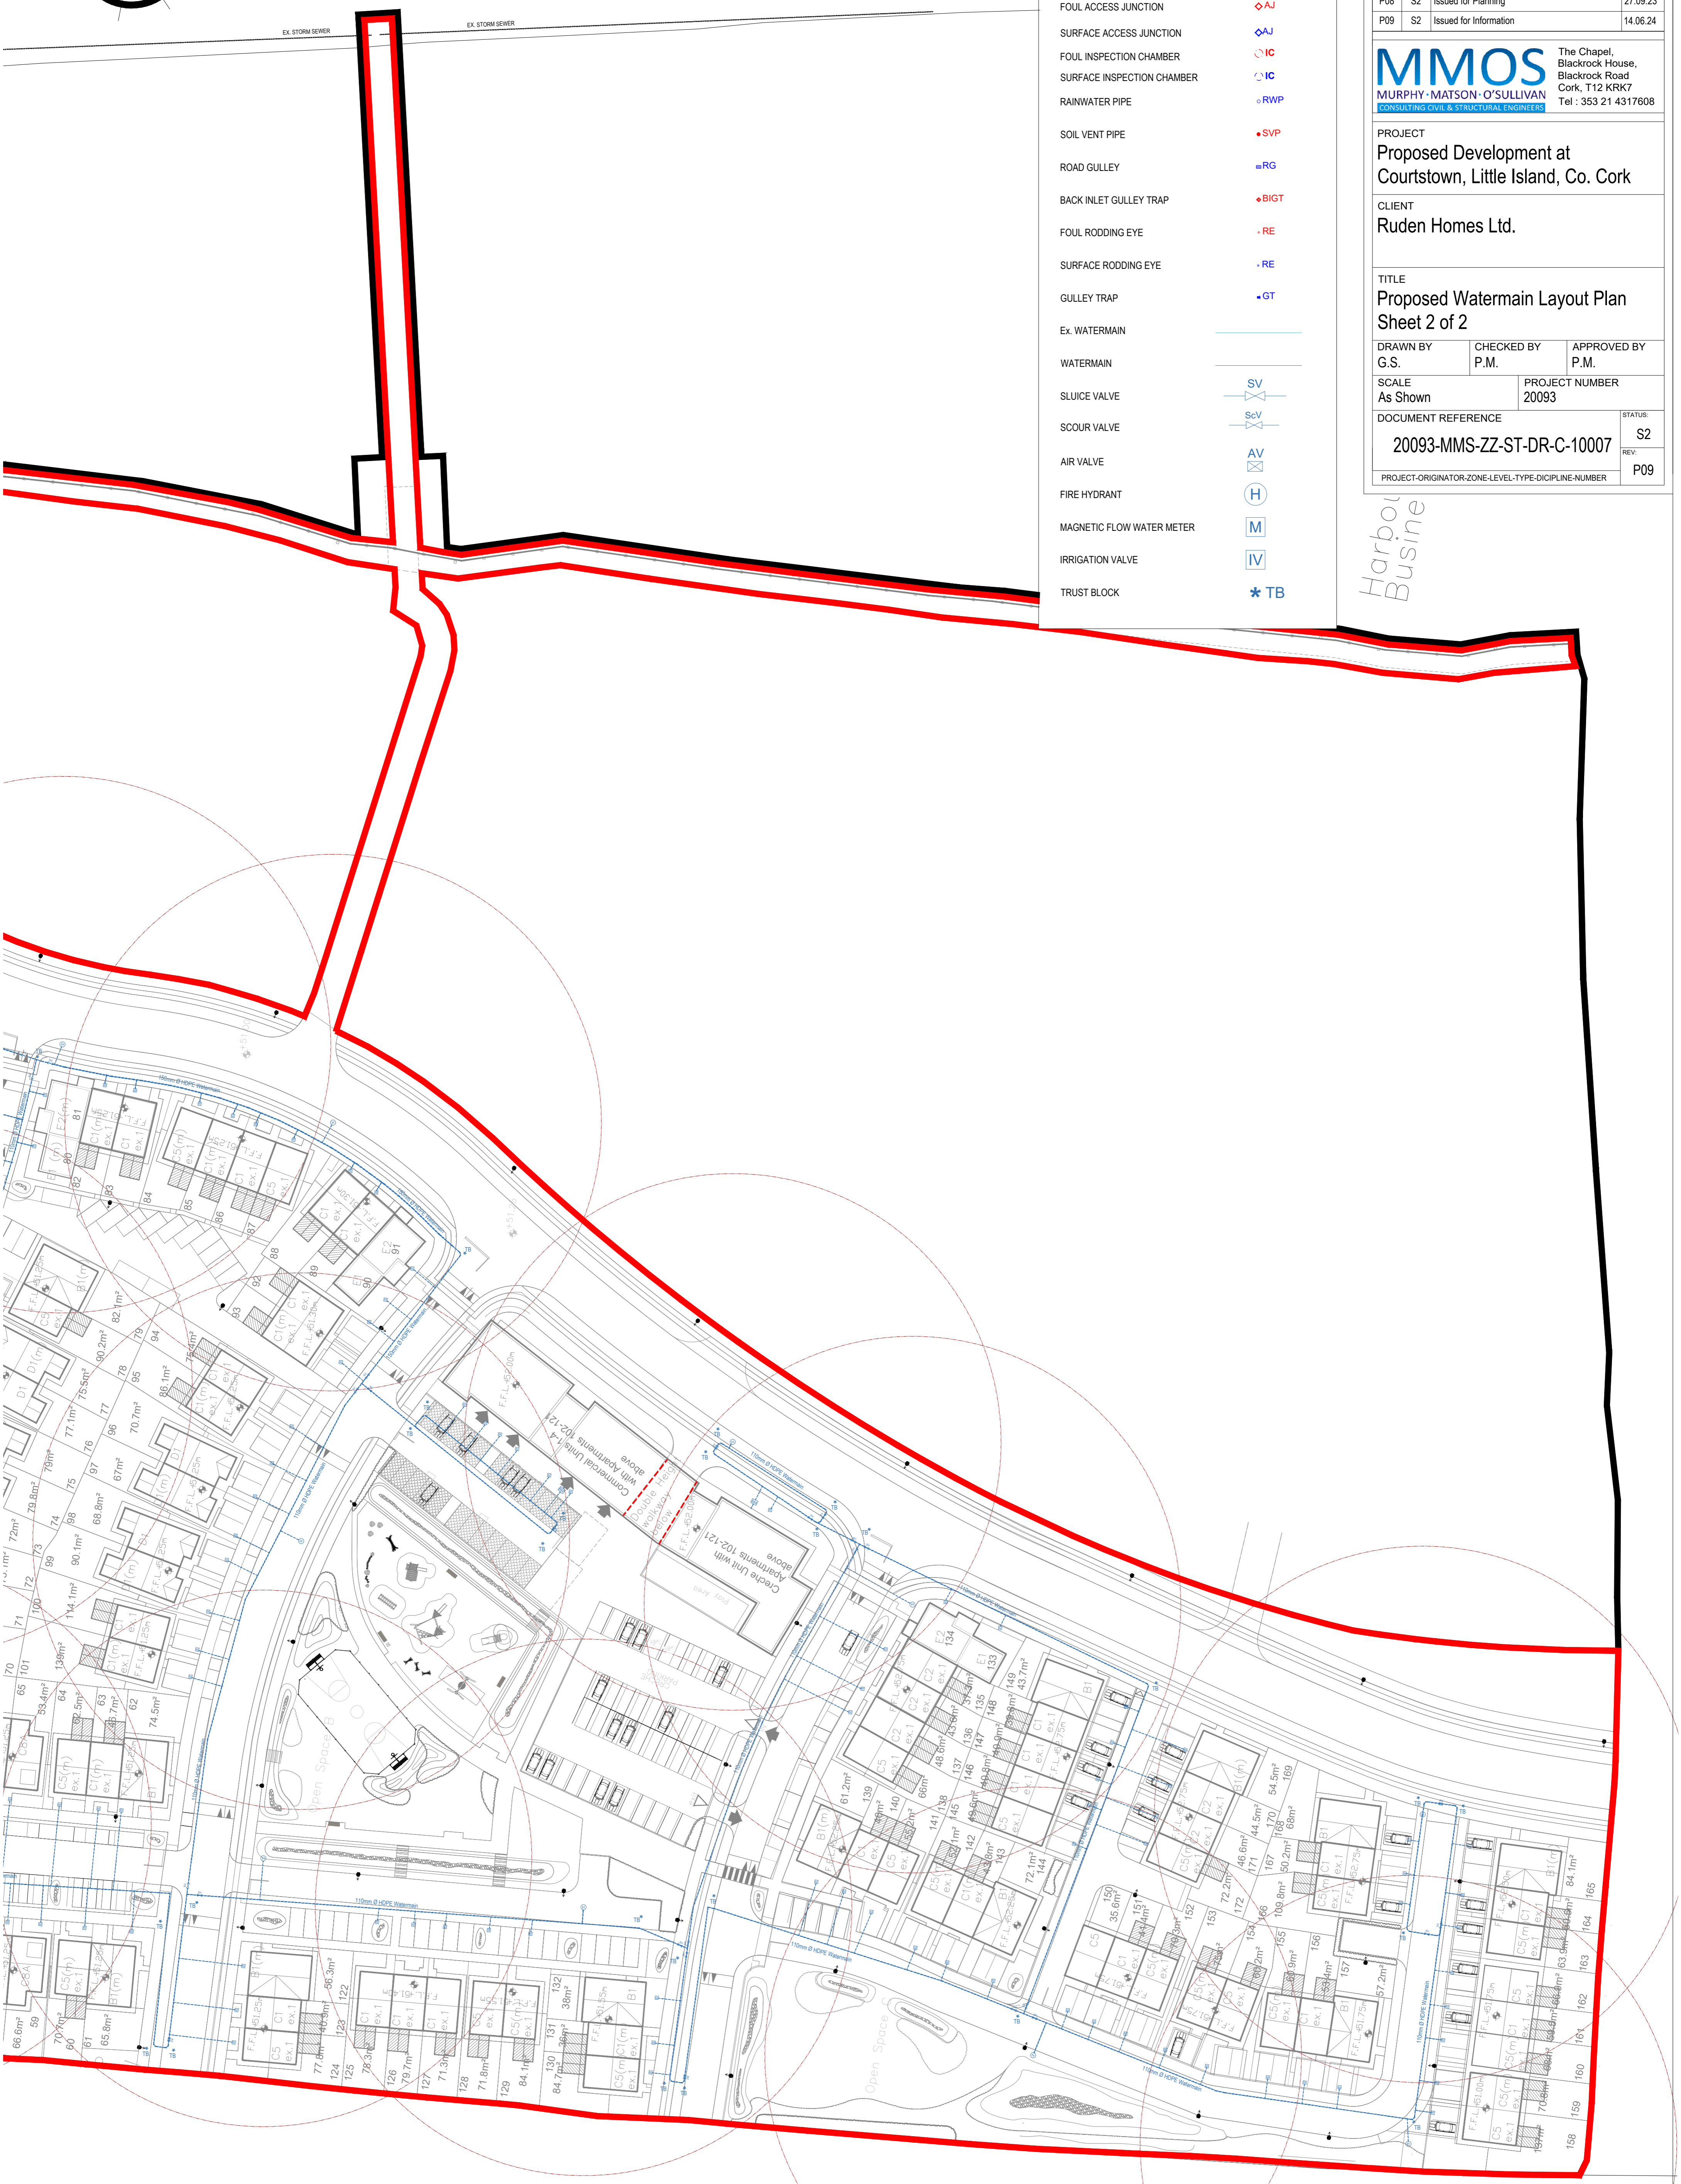

Harbour
Busine